


ERECTED
 TYPE
 FOUNDATION
 WALLS
 ROOF { TYPE
 PITCH
 HEATING

FRAME
 PILES
 2"x12"
 GABLE - SHINGLES
 &
 STOVE

FLOOR
 FINISH { OUTSIDE
 INSIDE
 CEILING
 LIGHTING
 SANITARY FACILITIES

SOUTHERN DIV.
 WILLOW SPRINGS SUB
 STA. No C 2988
 7/8"x3/4" Y.P.
 1"x12" E BATTENS,
 7/8"x5/4" MATCHED E BEED
 7/8"x5/4" H. & B. - 10'-6" HT. WAITING RM. - 11'-0" FR'T. RM.
 KEROSENE
 OUTSIDE TOILETS

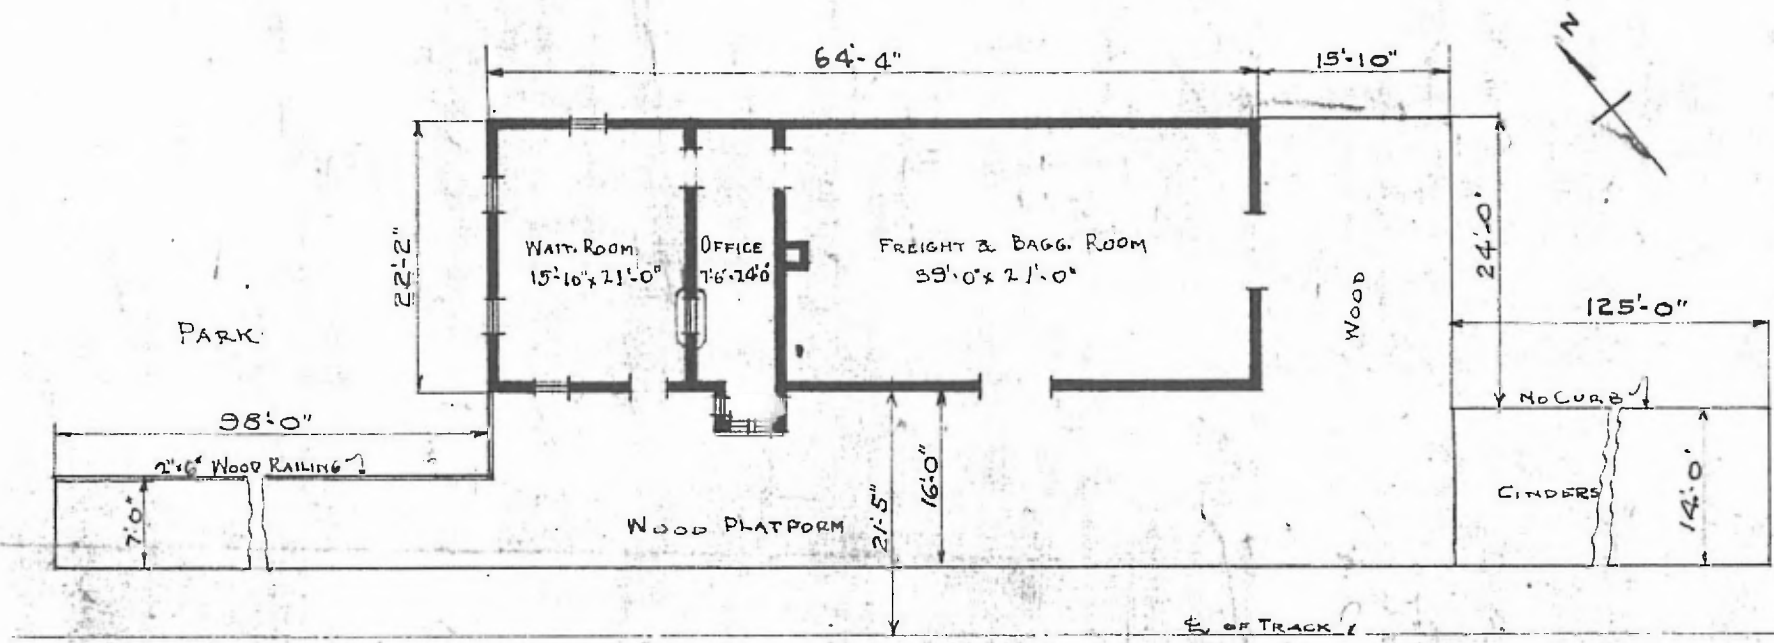

FLOOR PLAN
 SCALE: 1/8" = 1'-0"

COMBINATION STATION AT
 BURNHAM, MO.

FEB. 13, 1916